


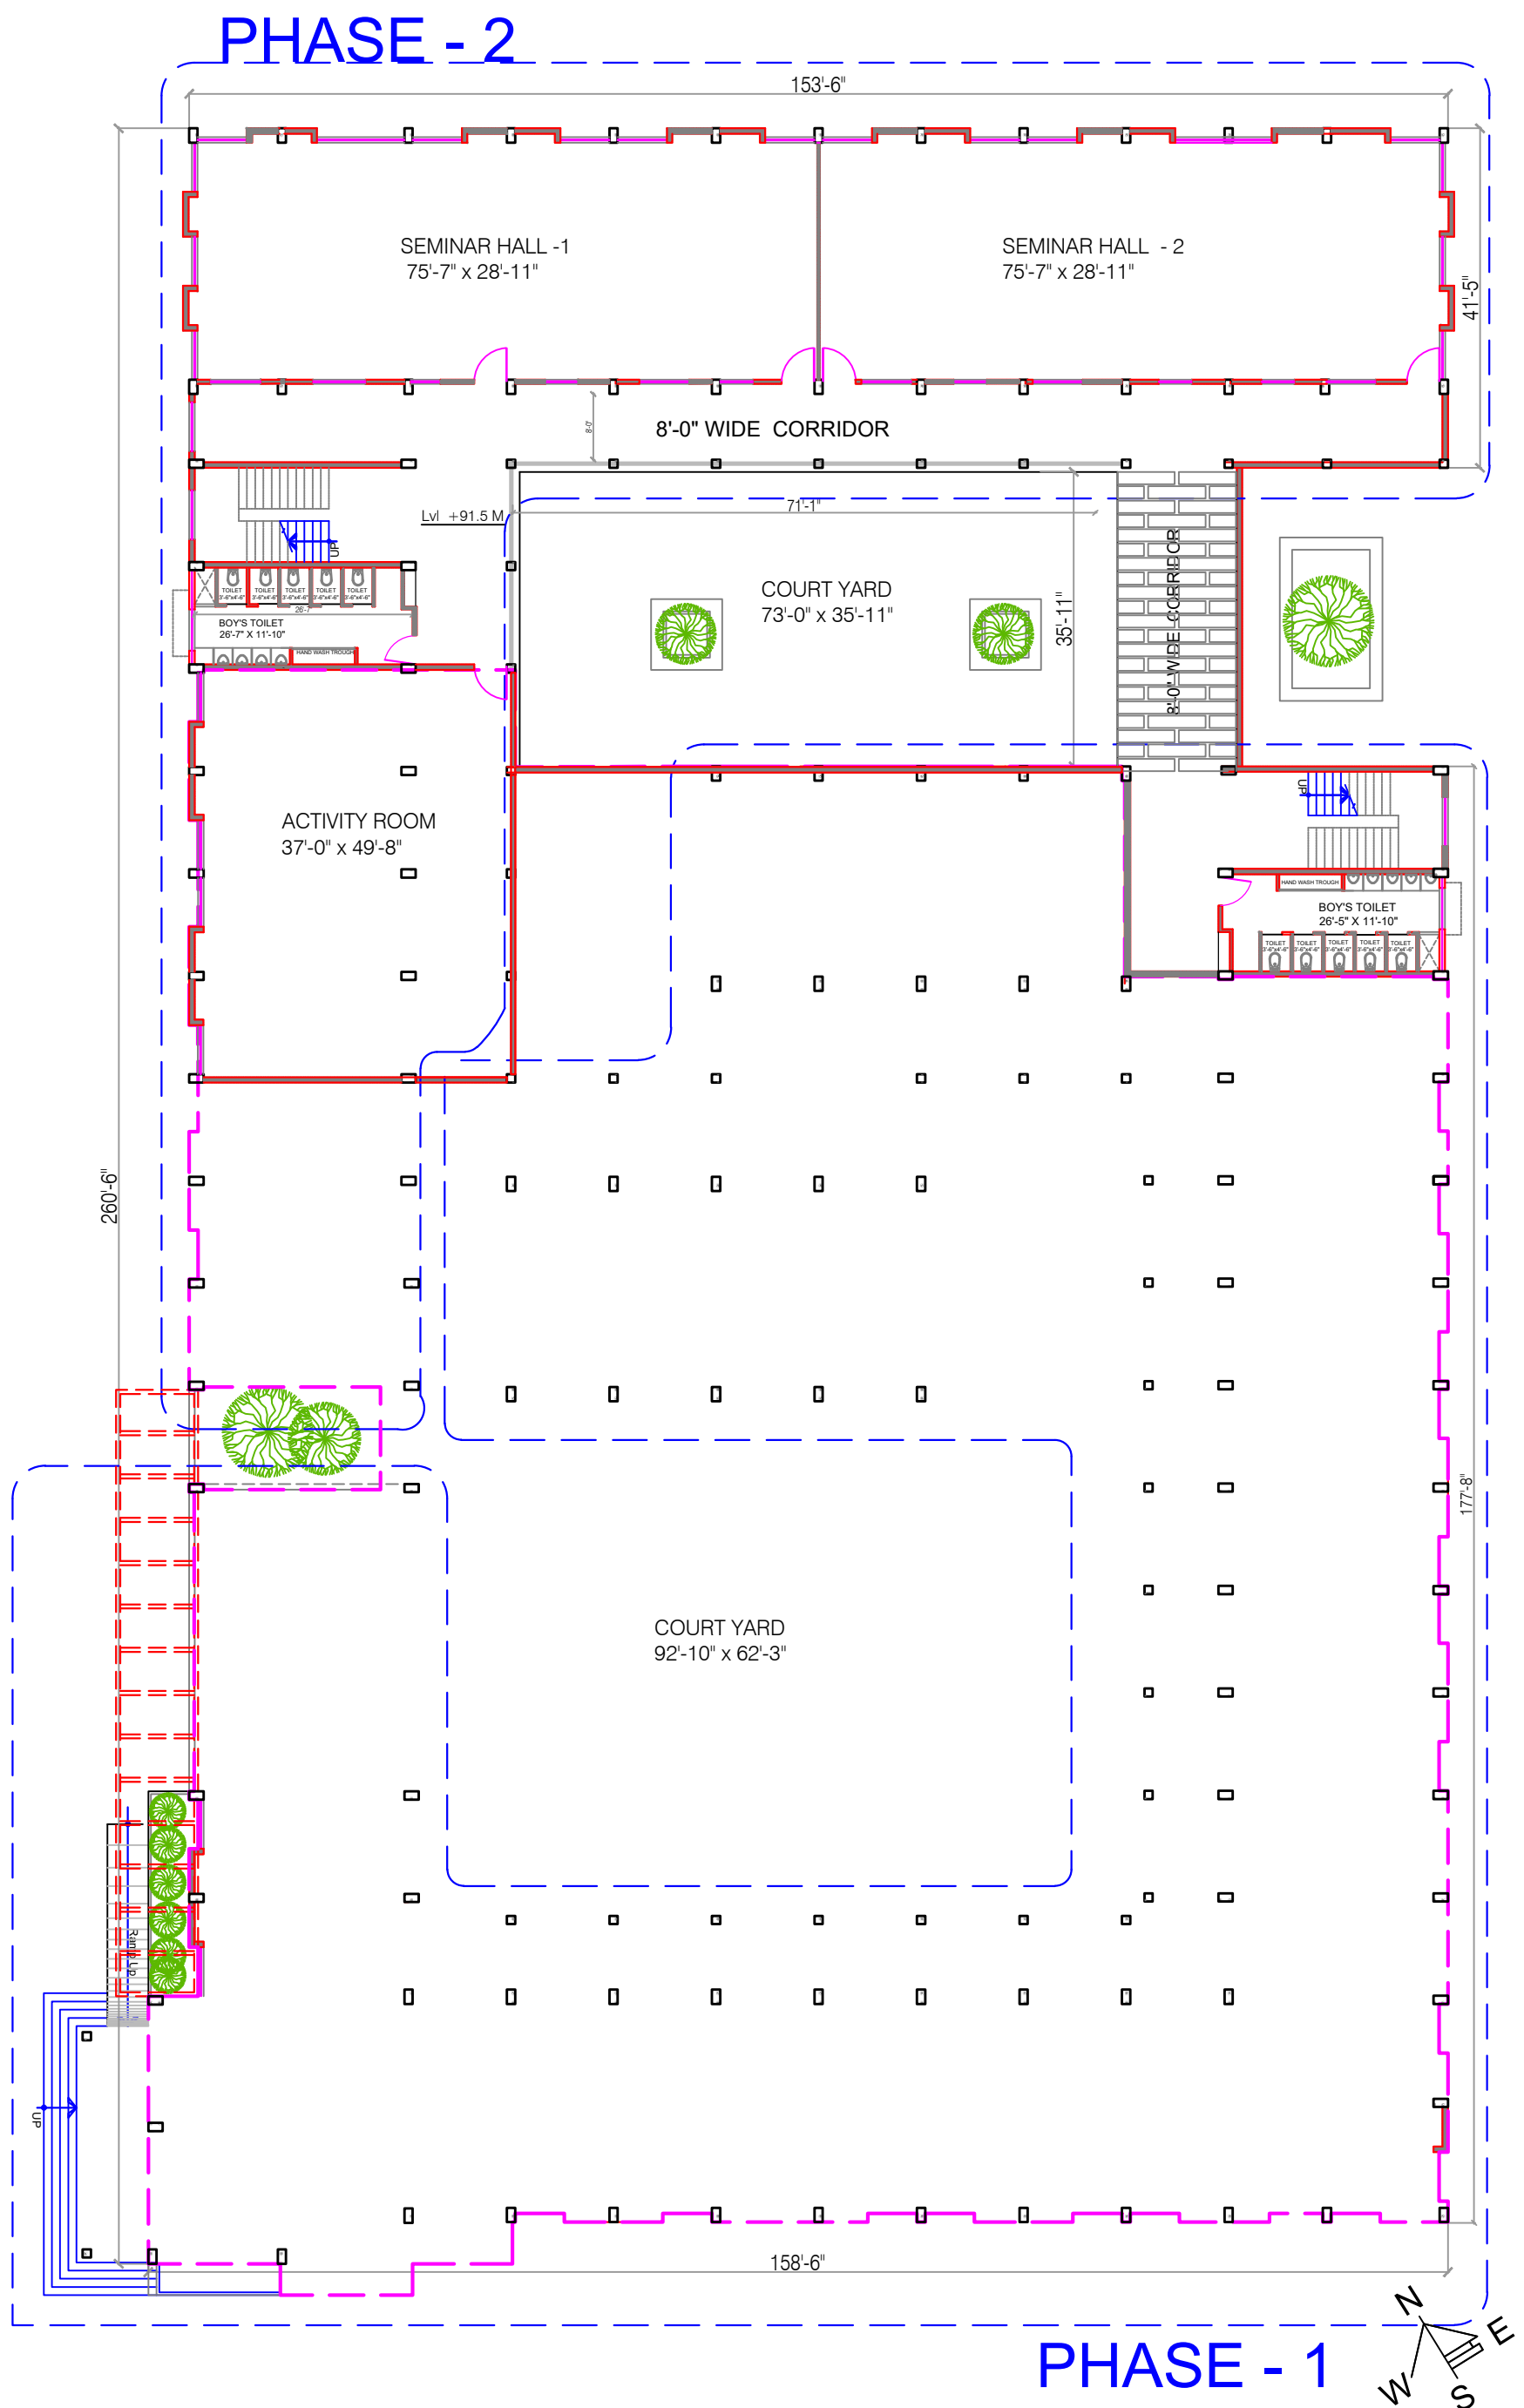

PROJECT :	Drawing Title :	RELEASED FOR :	DEALT BY: ASD	ARCHITECTS:
Proposed B.Ed College building at Mummigatti at Dharwad	LOWER GROUND FLOOR PLAN	☐ PRELIMINARY ☐ SCHEME ☐ INFORMATION ☐ APPROVAL ☐ TENDER ☐ CONSTRUCTION	DRAWN BY:Pk DATE : 18.09.2024 SCALE : 1:60	M Y S O R E CONSULTANTS PVT.LTD ARCHITECTURE ENGINEERING INTERIORS URBAN DESIGN 14/3,5th FLOOR,ANNEXE BUILDING, SRI ARAVIND BHAVAN,NRUPATUNGA ROAD, BANGALORE 560001 TEL : 080 - 22211758 / 658