



PHASE - 2

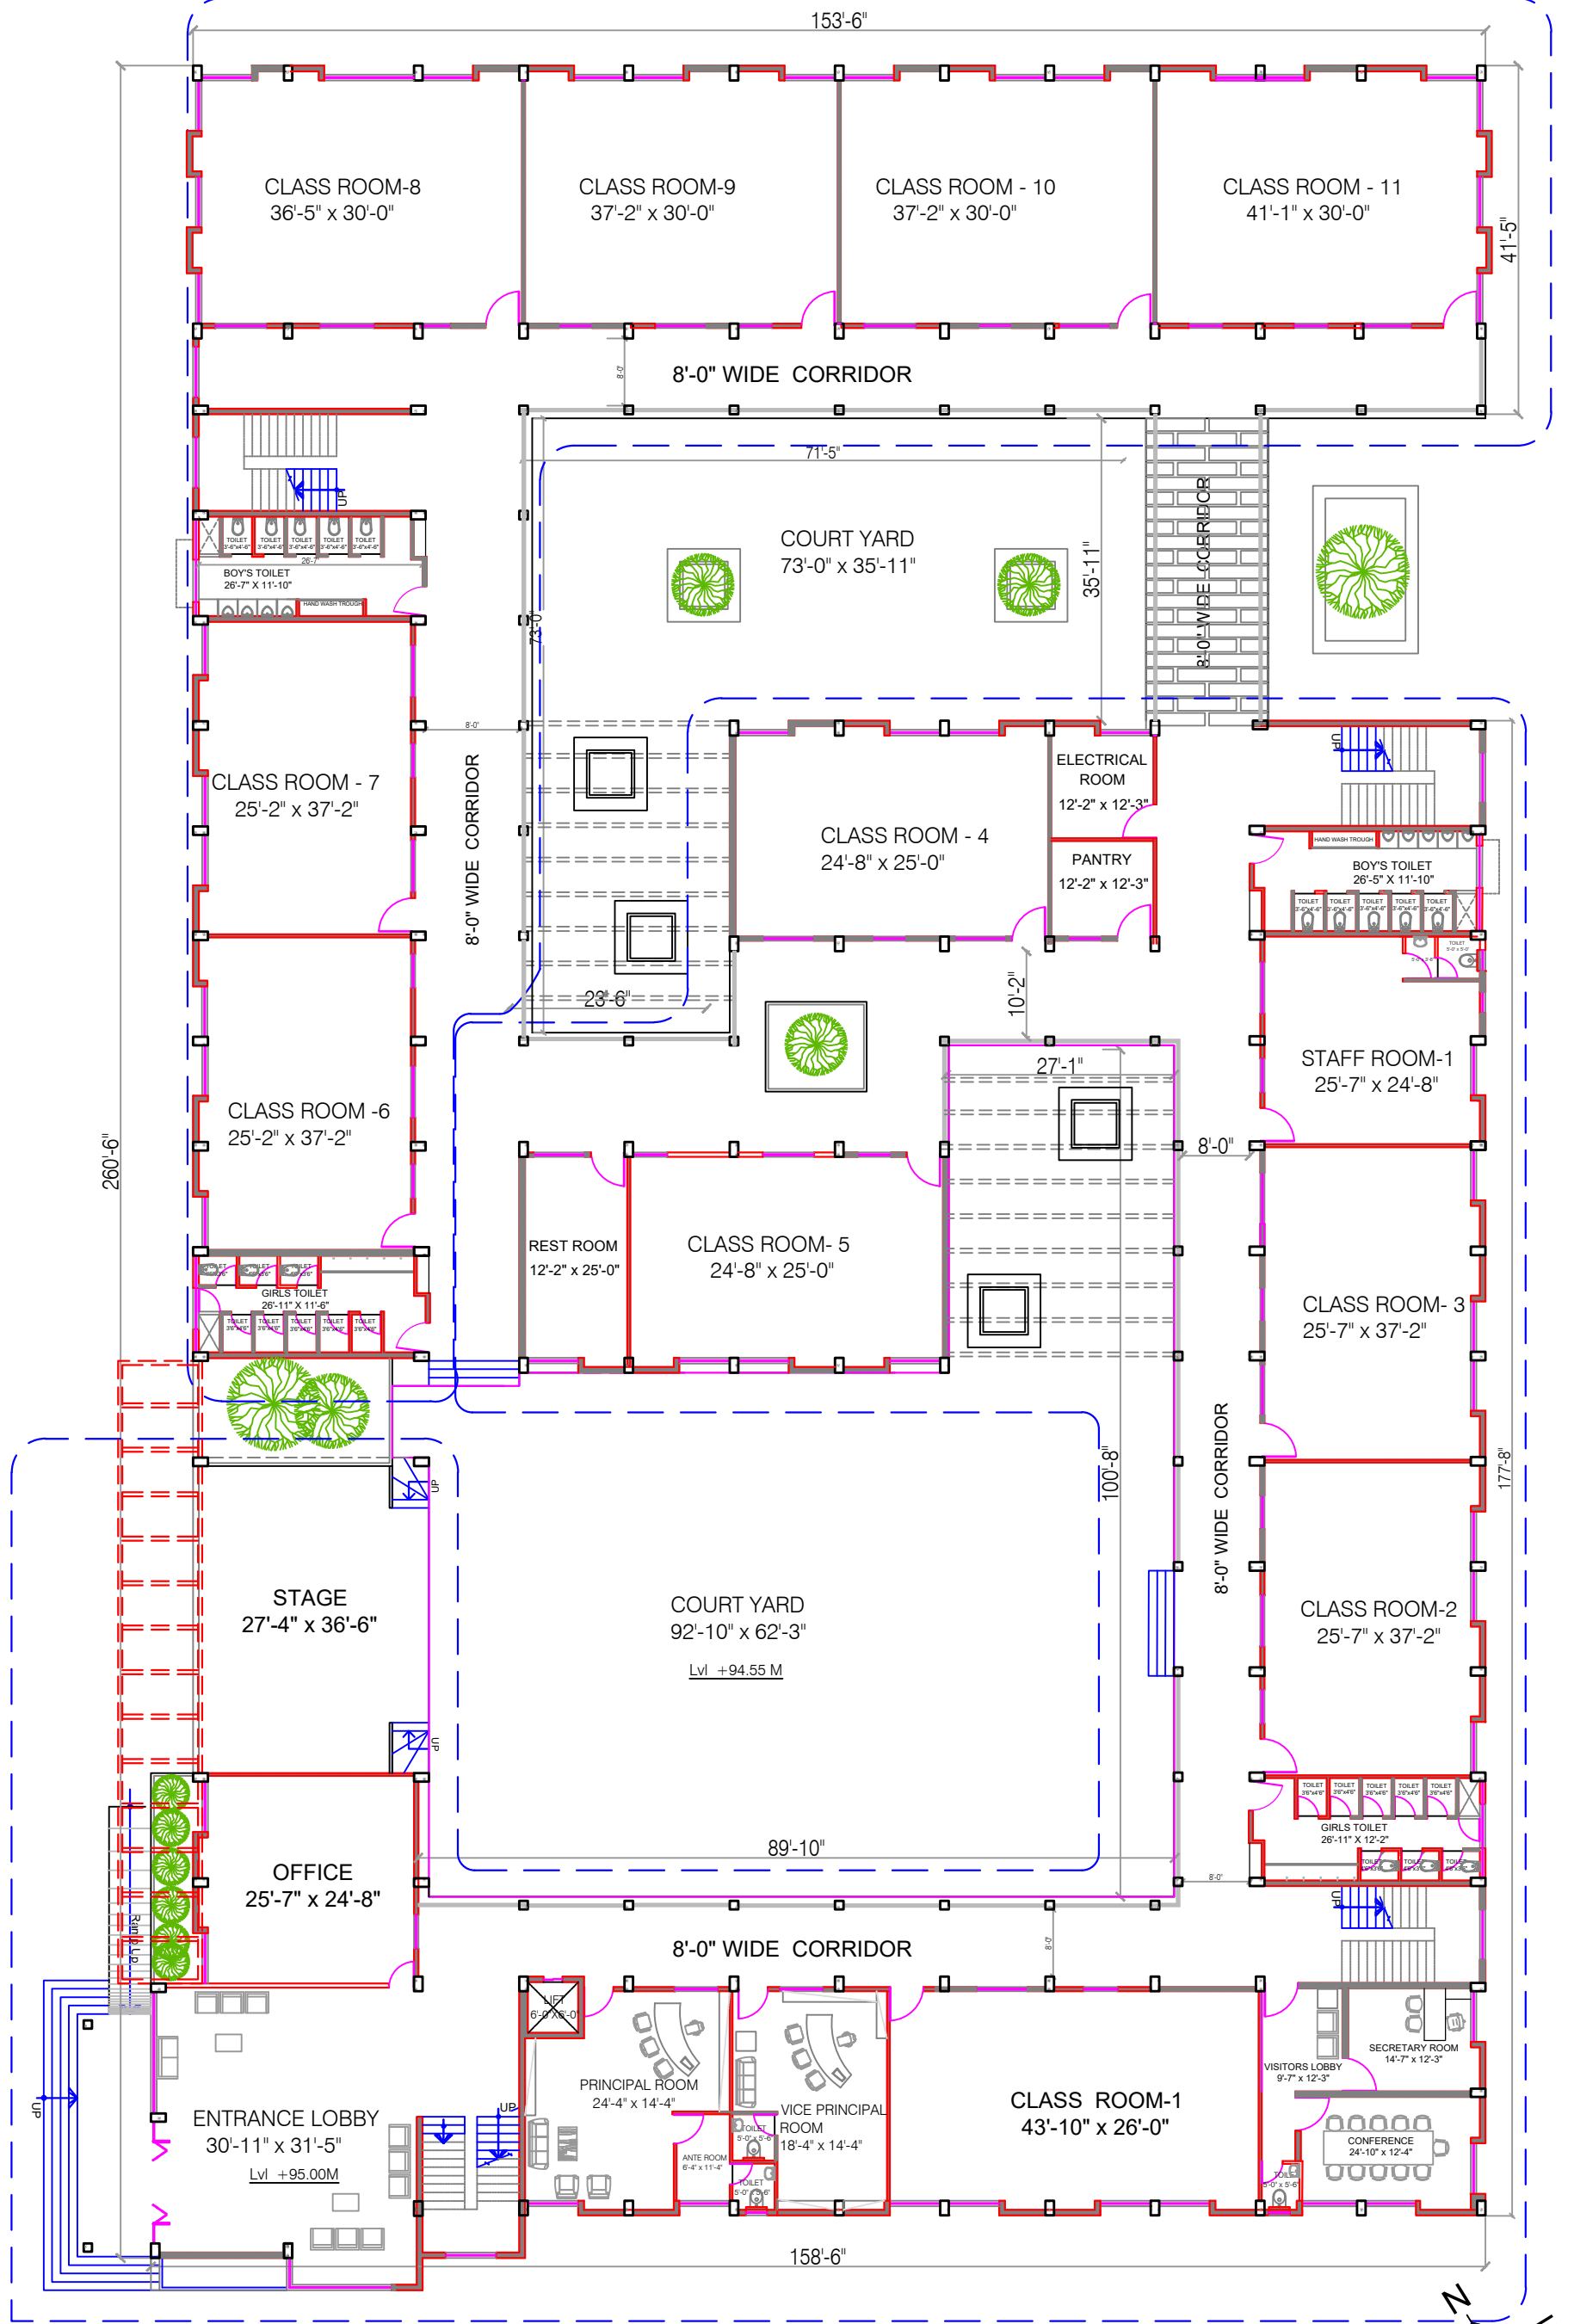

PHASE - 1

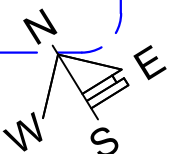

PROJECT :	Drawing Title :	RELEASED FOR :	DEALT BY: ASD	ARCHITECTS:
Proposed B.Ed College building at Mummigatti at Dharwad	UPPER GROUND FLOOR PLAN	☐ PRELIMINARY ☐ SCHEME ☐ INFORMATION ☐ APPROVAL ☐ TENDER ☐ CONSTRUCTION	DRAWN BY: Pk	MYSORE CONSULTANTS PVT.LTD ARCHITECTURE ENGINEERING INTERIORS URBAN DESIGN
			DATE : 18.09.2024	14/3,5th FLOOR,ANNEXE BUILDING, SRI ARAVIND BHAVAN,NRUPATUNGA ROAD, BANGALORE 560001 TEL : 080 - 22211758 / 658
			SCALE : 1:60	